


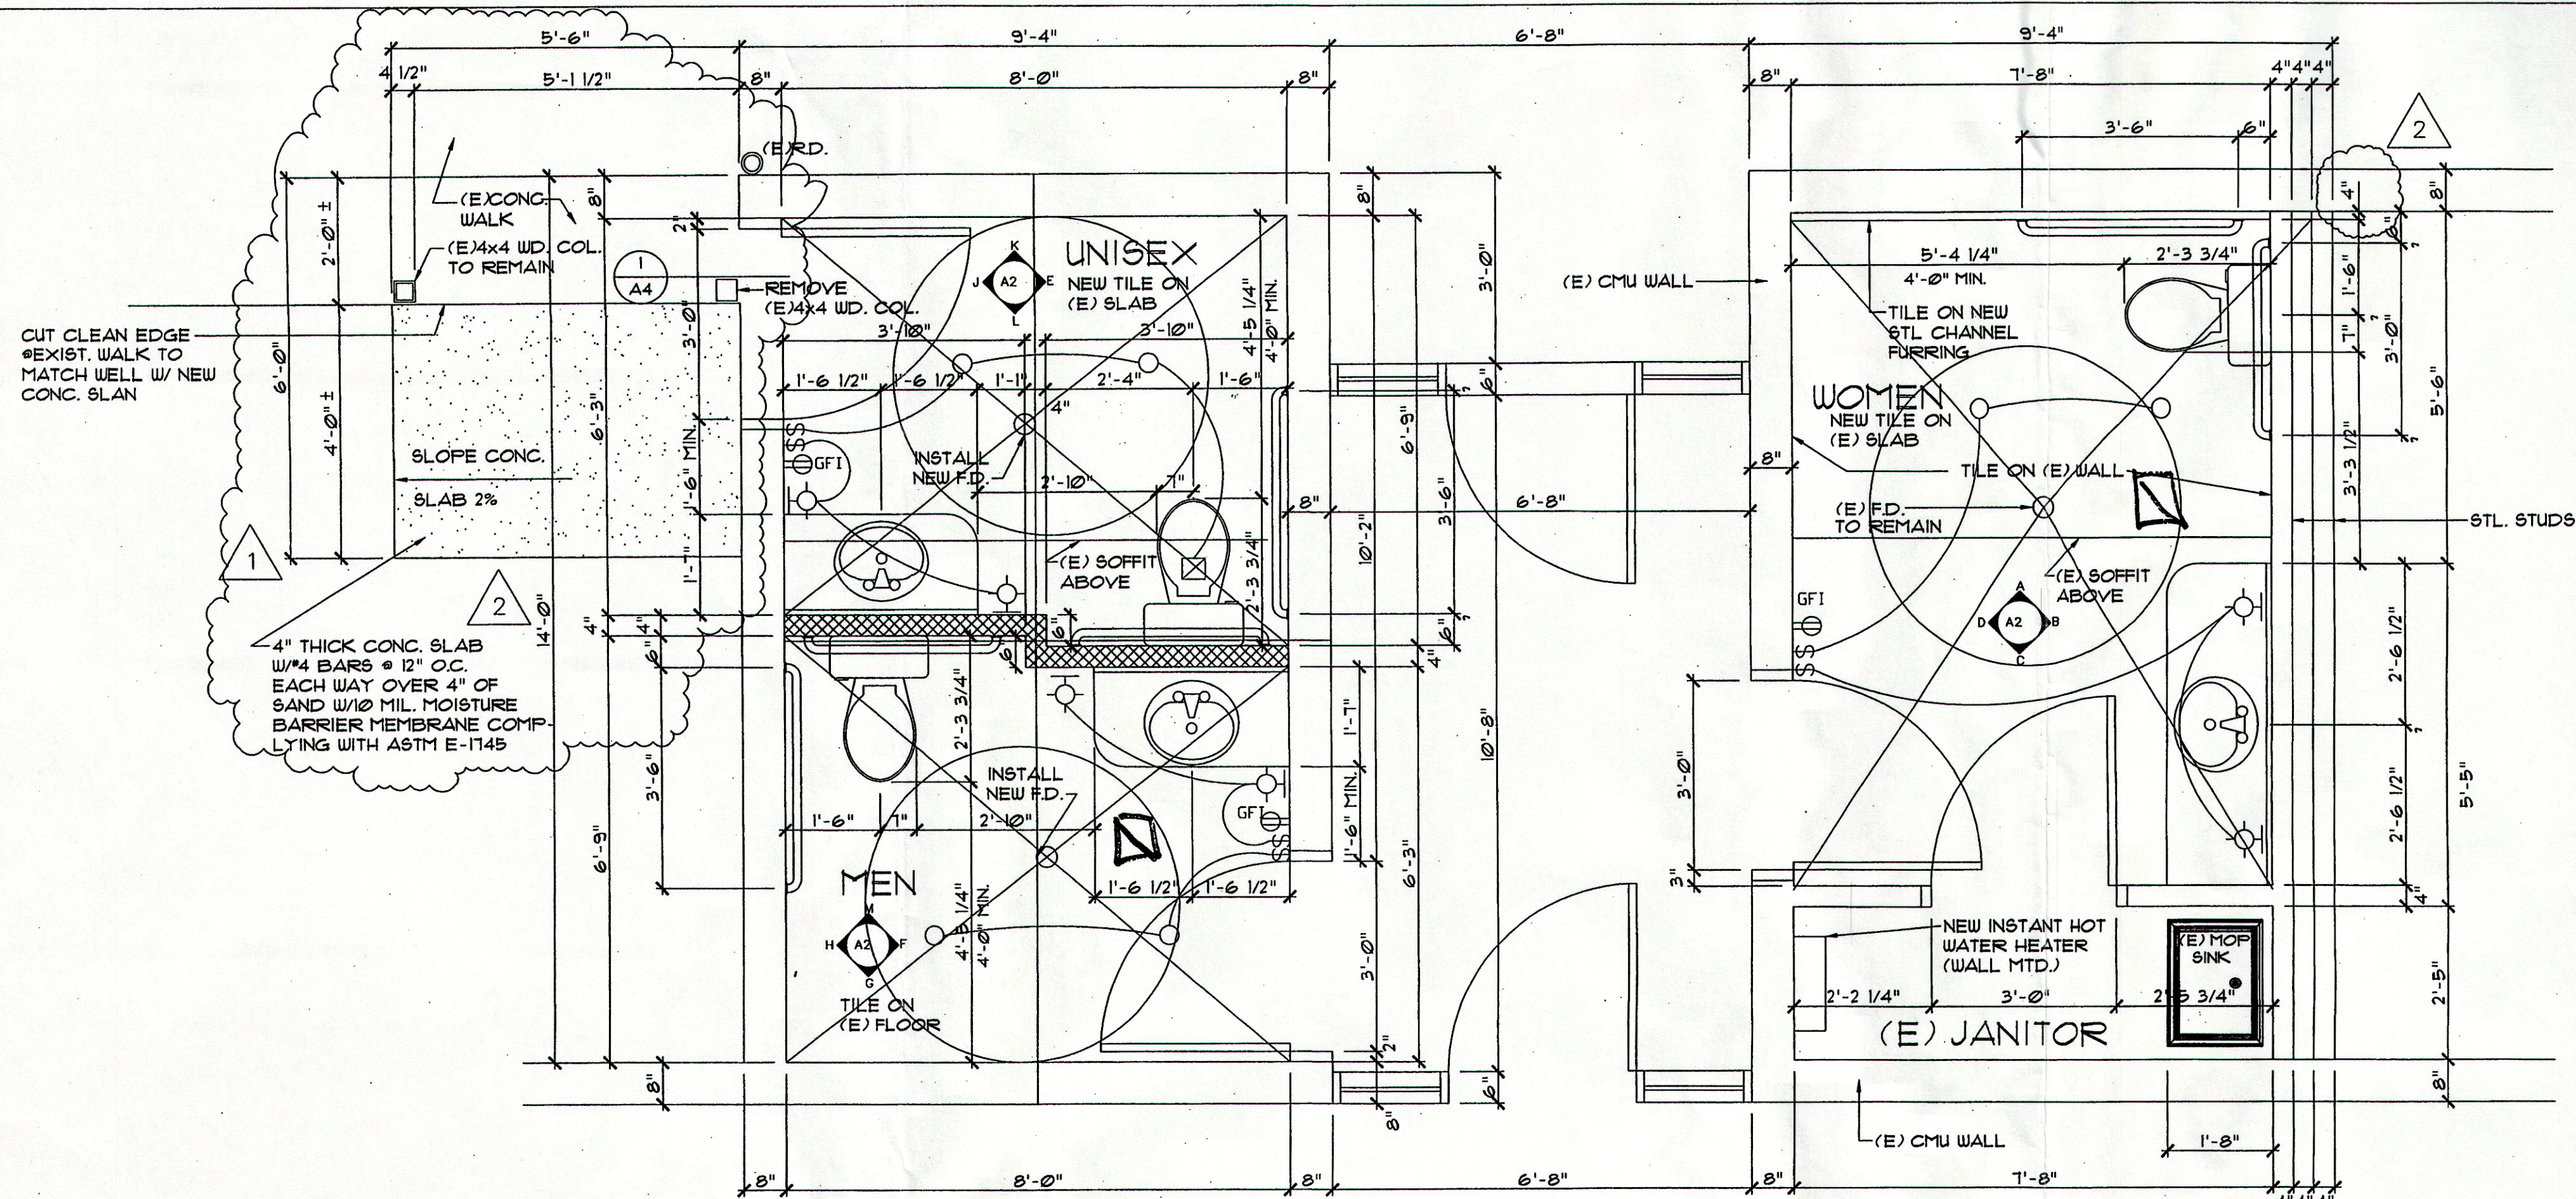

Fluor Drains to have
TRAP Pairs

1 PROPOSED FLOOR PLAN
SCALE 1/2" = 1'-0"


- WALL DESCRIPTIONS**
- DEMOLISH DASHED OBJECTS
 - EXISTING TO REMAIN
 - NEW STL. STUDS @ PARTITION

2 DEMOLITION PLAN
SCALE 1/2" = 1'-0"


NOTE
EXISTING FLOOR TILE AND SETTING BED TO BE REMOVED
PRIOR TO INSTALLATION OF NEW TILE ON (E) SLAB
IN BOTH RESTROOMS

ELECTRICAL LEGEND

- GROUND FAULT INTERRUPT OUTLET
- RECESSED DOWNLIGHT
- WALL MOUNTED FIXTURE
- EXHAUST FAN
- SWITCH

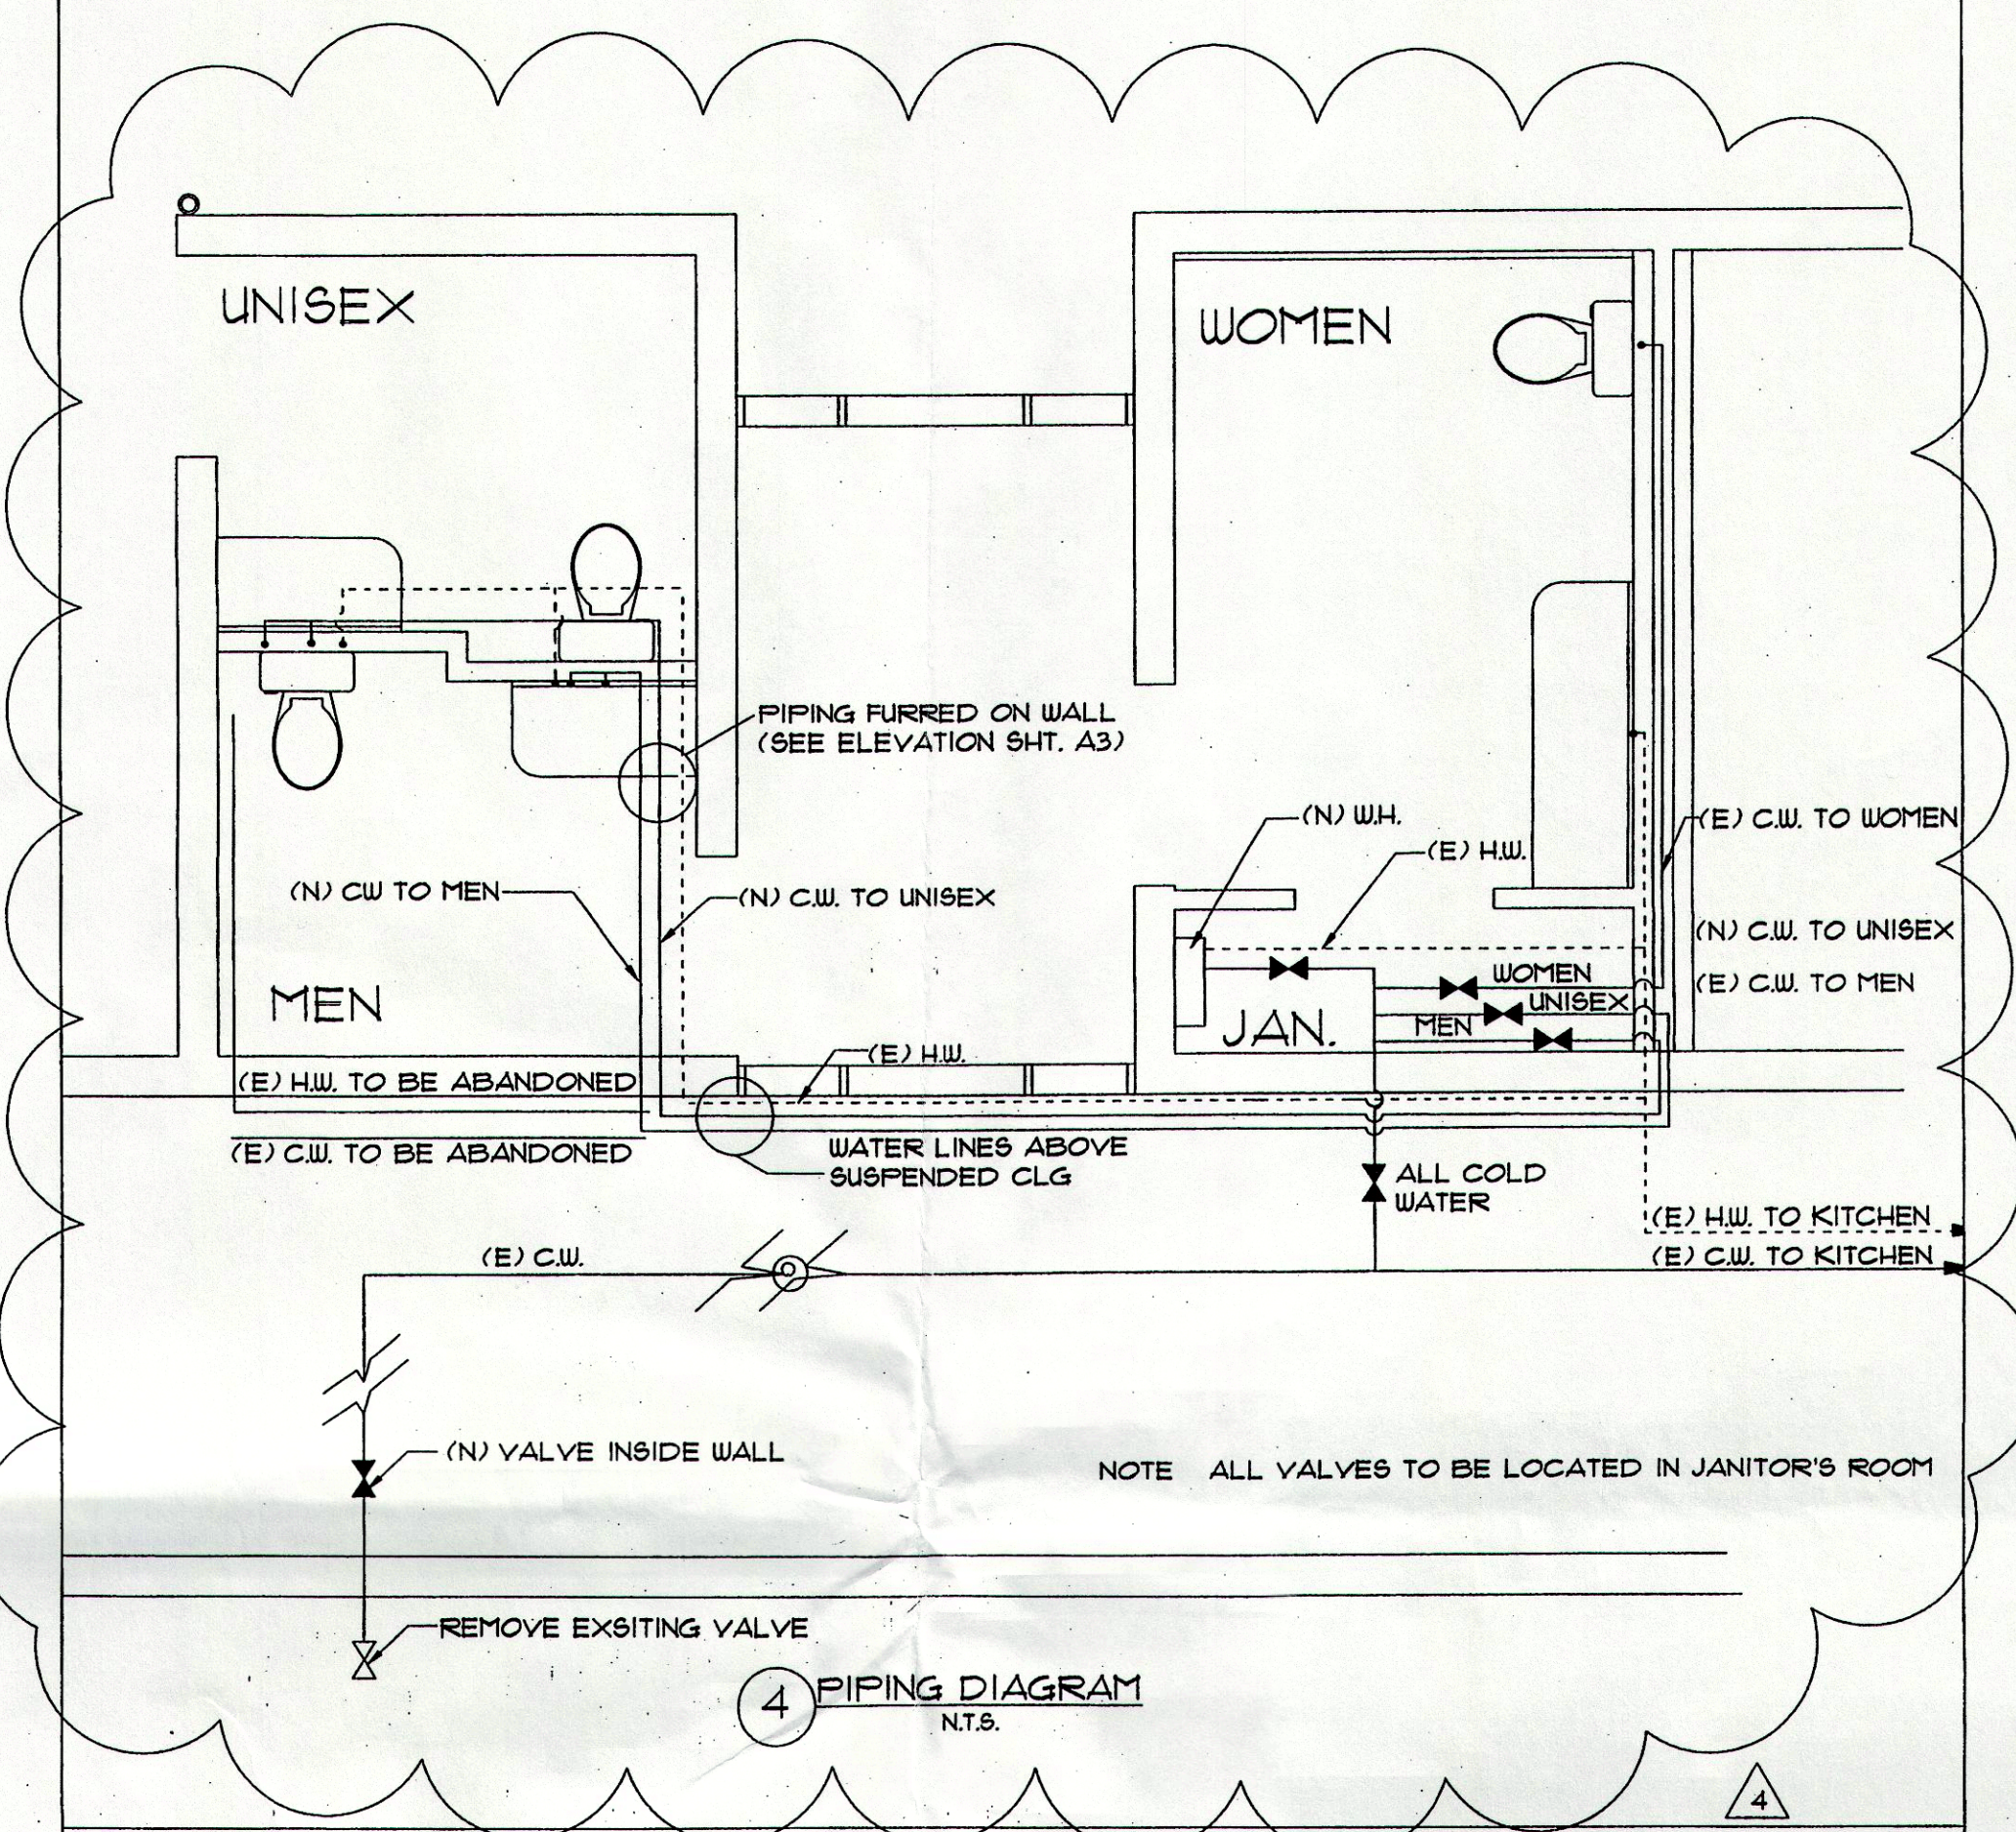

4 PIPING DIAGRAM
N.T.S.

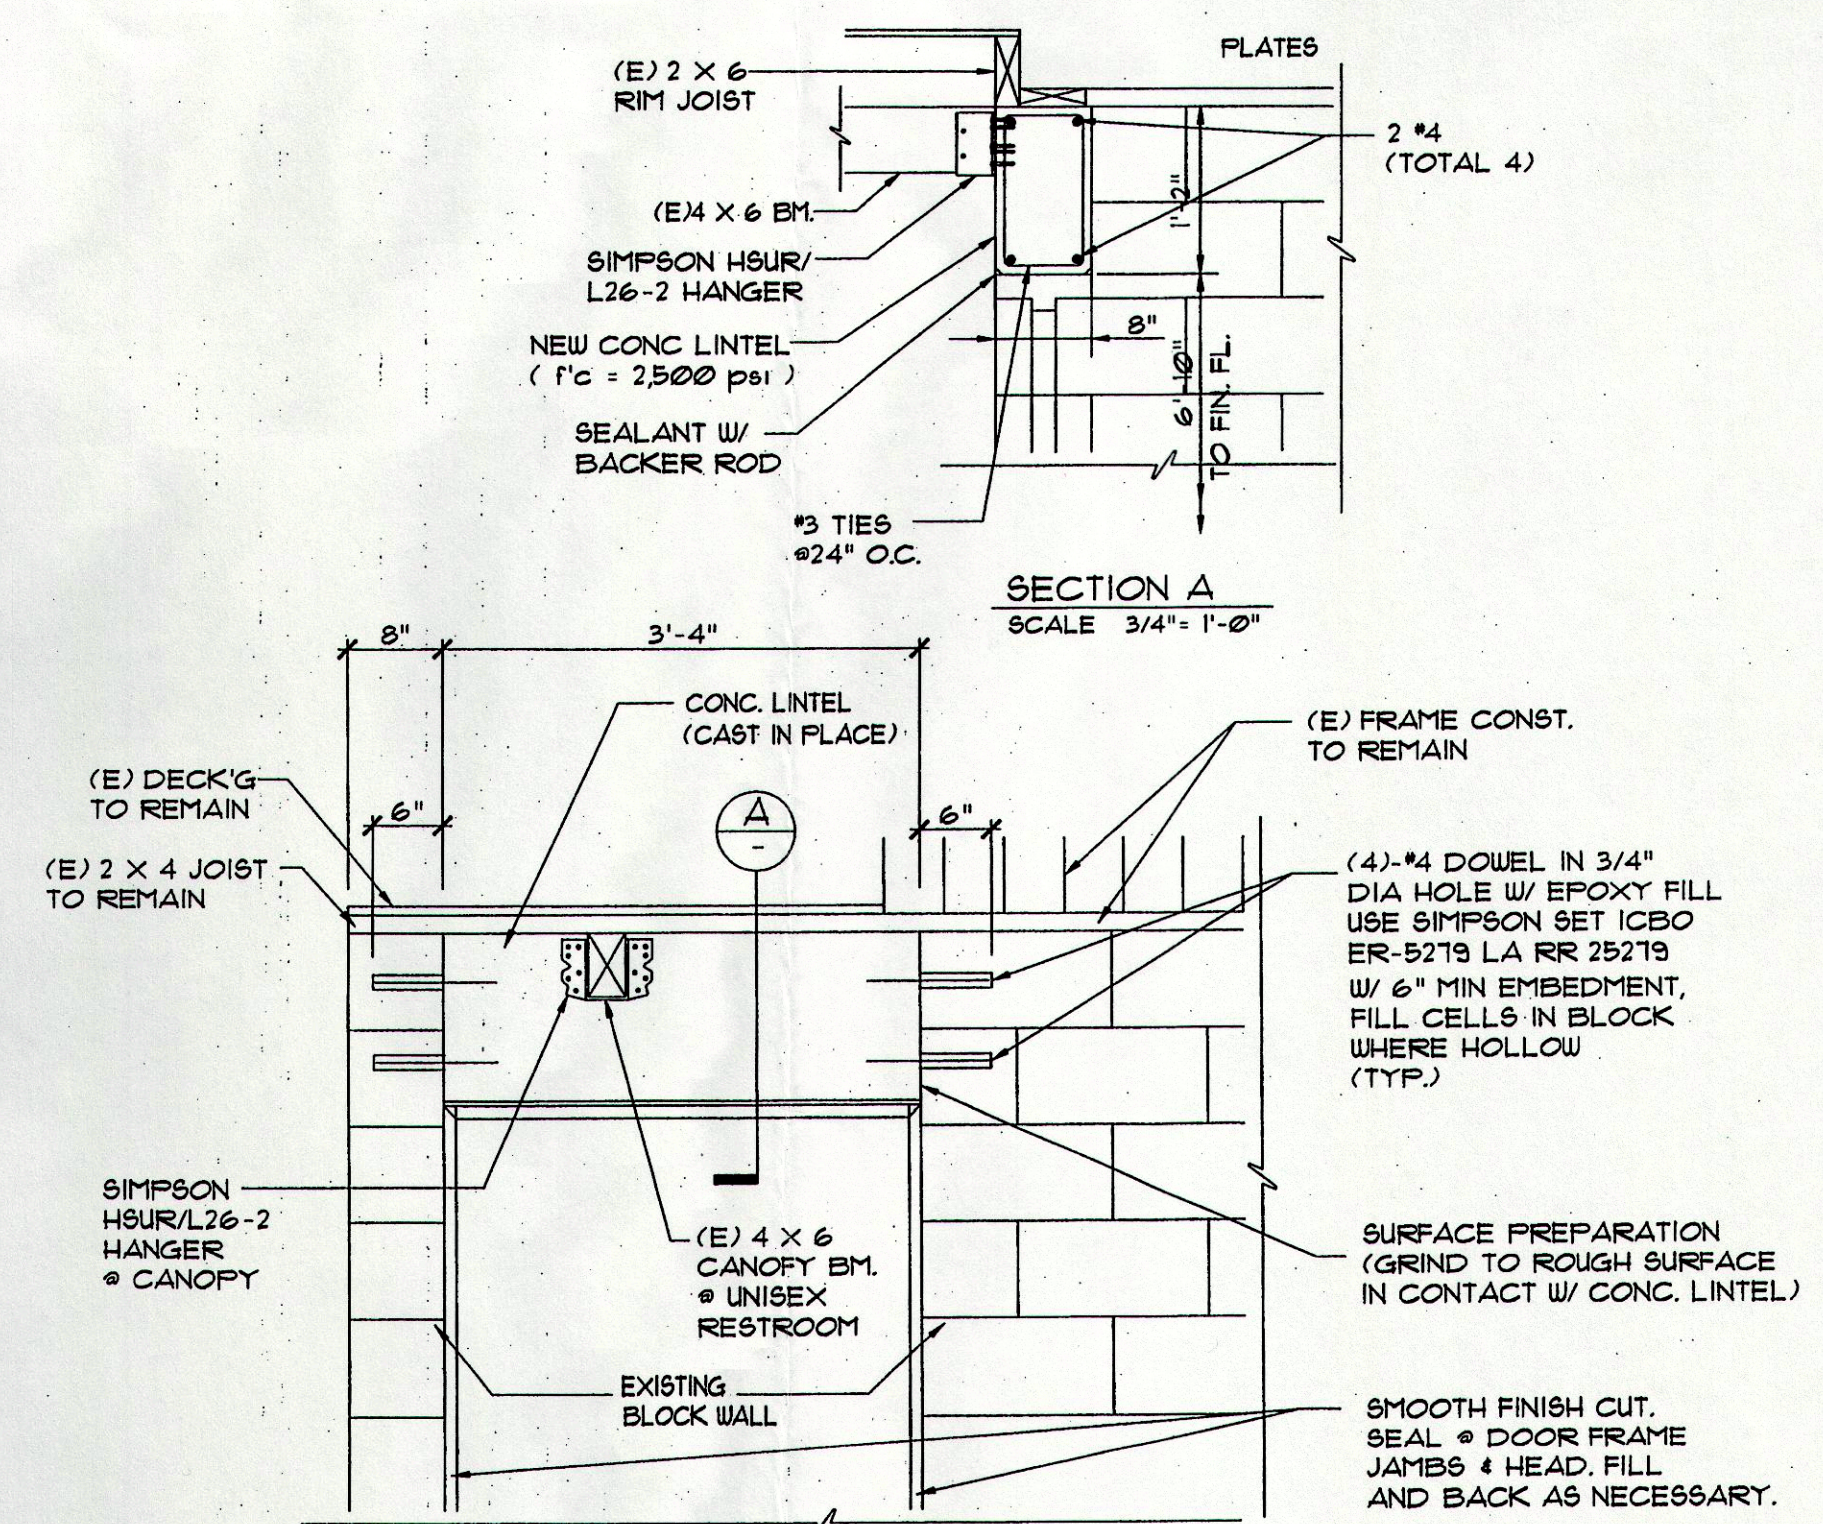

3 DOOR OPENING DETAIL
SCALE 3/4" = 1'-0"

NOTE
WOMEN'S & MEN'S RESTROOM DOORS SHALL BE NEW 3'-0" X 6'-8" X 1 3/4" INT. HM DOORS W/ KD.MTL.FRAMES
UNISEX RESTROOM DOOR SHALL BE 3'-0" X 6'-8" X 1 3/4" EXT. HM DOOR W/ KD.EXT.MTL.FRAME.

"All Great Projects Start With JMC"

DATE:	7/9/08
BY:	S.H. 822/08
CHL	827/08
D.H.	9/29/10

REVISIONS:	NO.	1	2	3	4
SLAB ADDED AT EXTERIOR	1	SLAB ADDED AT EXTERIOR	2	NOTE DIMENSION AND (E) COLUMNS	3
ADDED DETAIL 3	4	ADDED DETAIL 3	5	PIPING DIAGRAM	6

PROFESSIONAL ENGINEER
JMC
John M. Crankshaft Consultants, Inc.
411 N. Harbor Blvd., Suite 201
San Pedro, CA 90731
P: 310.241.6590
F: 310.241.8871
www.jmc2.com

CITY OF RANCHO PALOS VERDES
COMMUNITY DEVELOPMENT DEPARTMENT RESTROOM ADA COMPLIANCE
30940 HAWTHORNE BLVD.
RANCHO PALOS VERDES, CA 90275

PROJECT NO. 20080019.00
SCALE 1/2" = 1'-0"
DATE 9/29/10
DESIGNED BY DAVID HOPKINS
DRAWN BY STEVE HOPKINS
CHECKED BY DAVID HOPKINS
SHEET NO. A2
2 OF 4 SHTS