




Don't You, Inc. has been granted its express license, its common law copyright, for these plans, these drawings, and these specifications, and they are to be used only for the project and site shown on these plans, drawings, and specifications, and they are not to be used for any other project or site without the written permission and consent of Don't You, Inc.

ELECTRICAL ROOF PLAN

P:\Dante\Yan\Proj\97356\97356.dwg Rev: 07 2004 - 1.45m

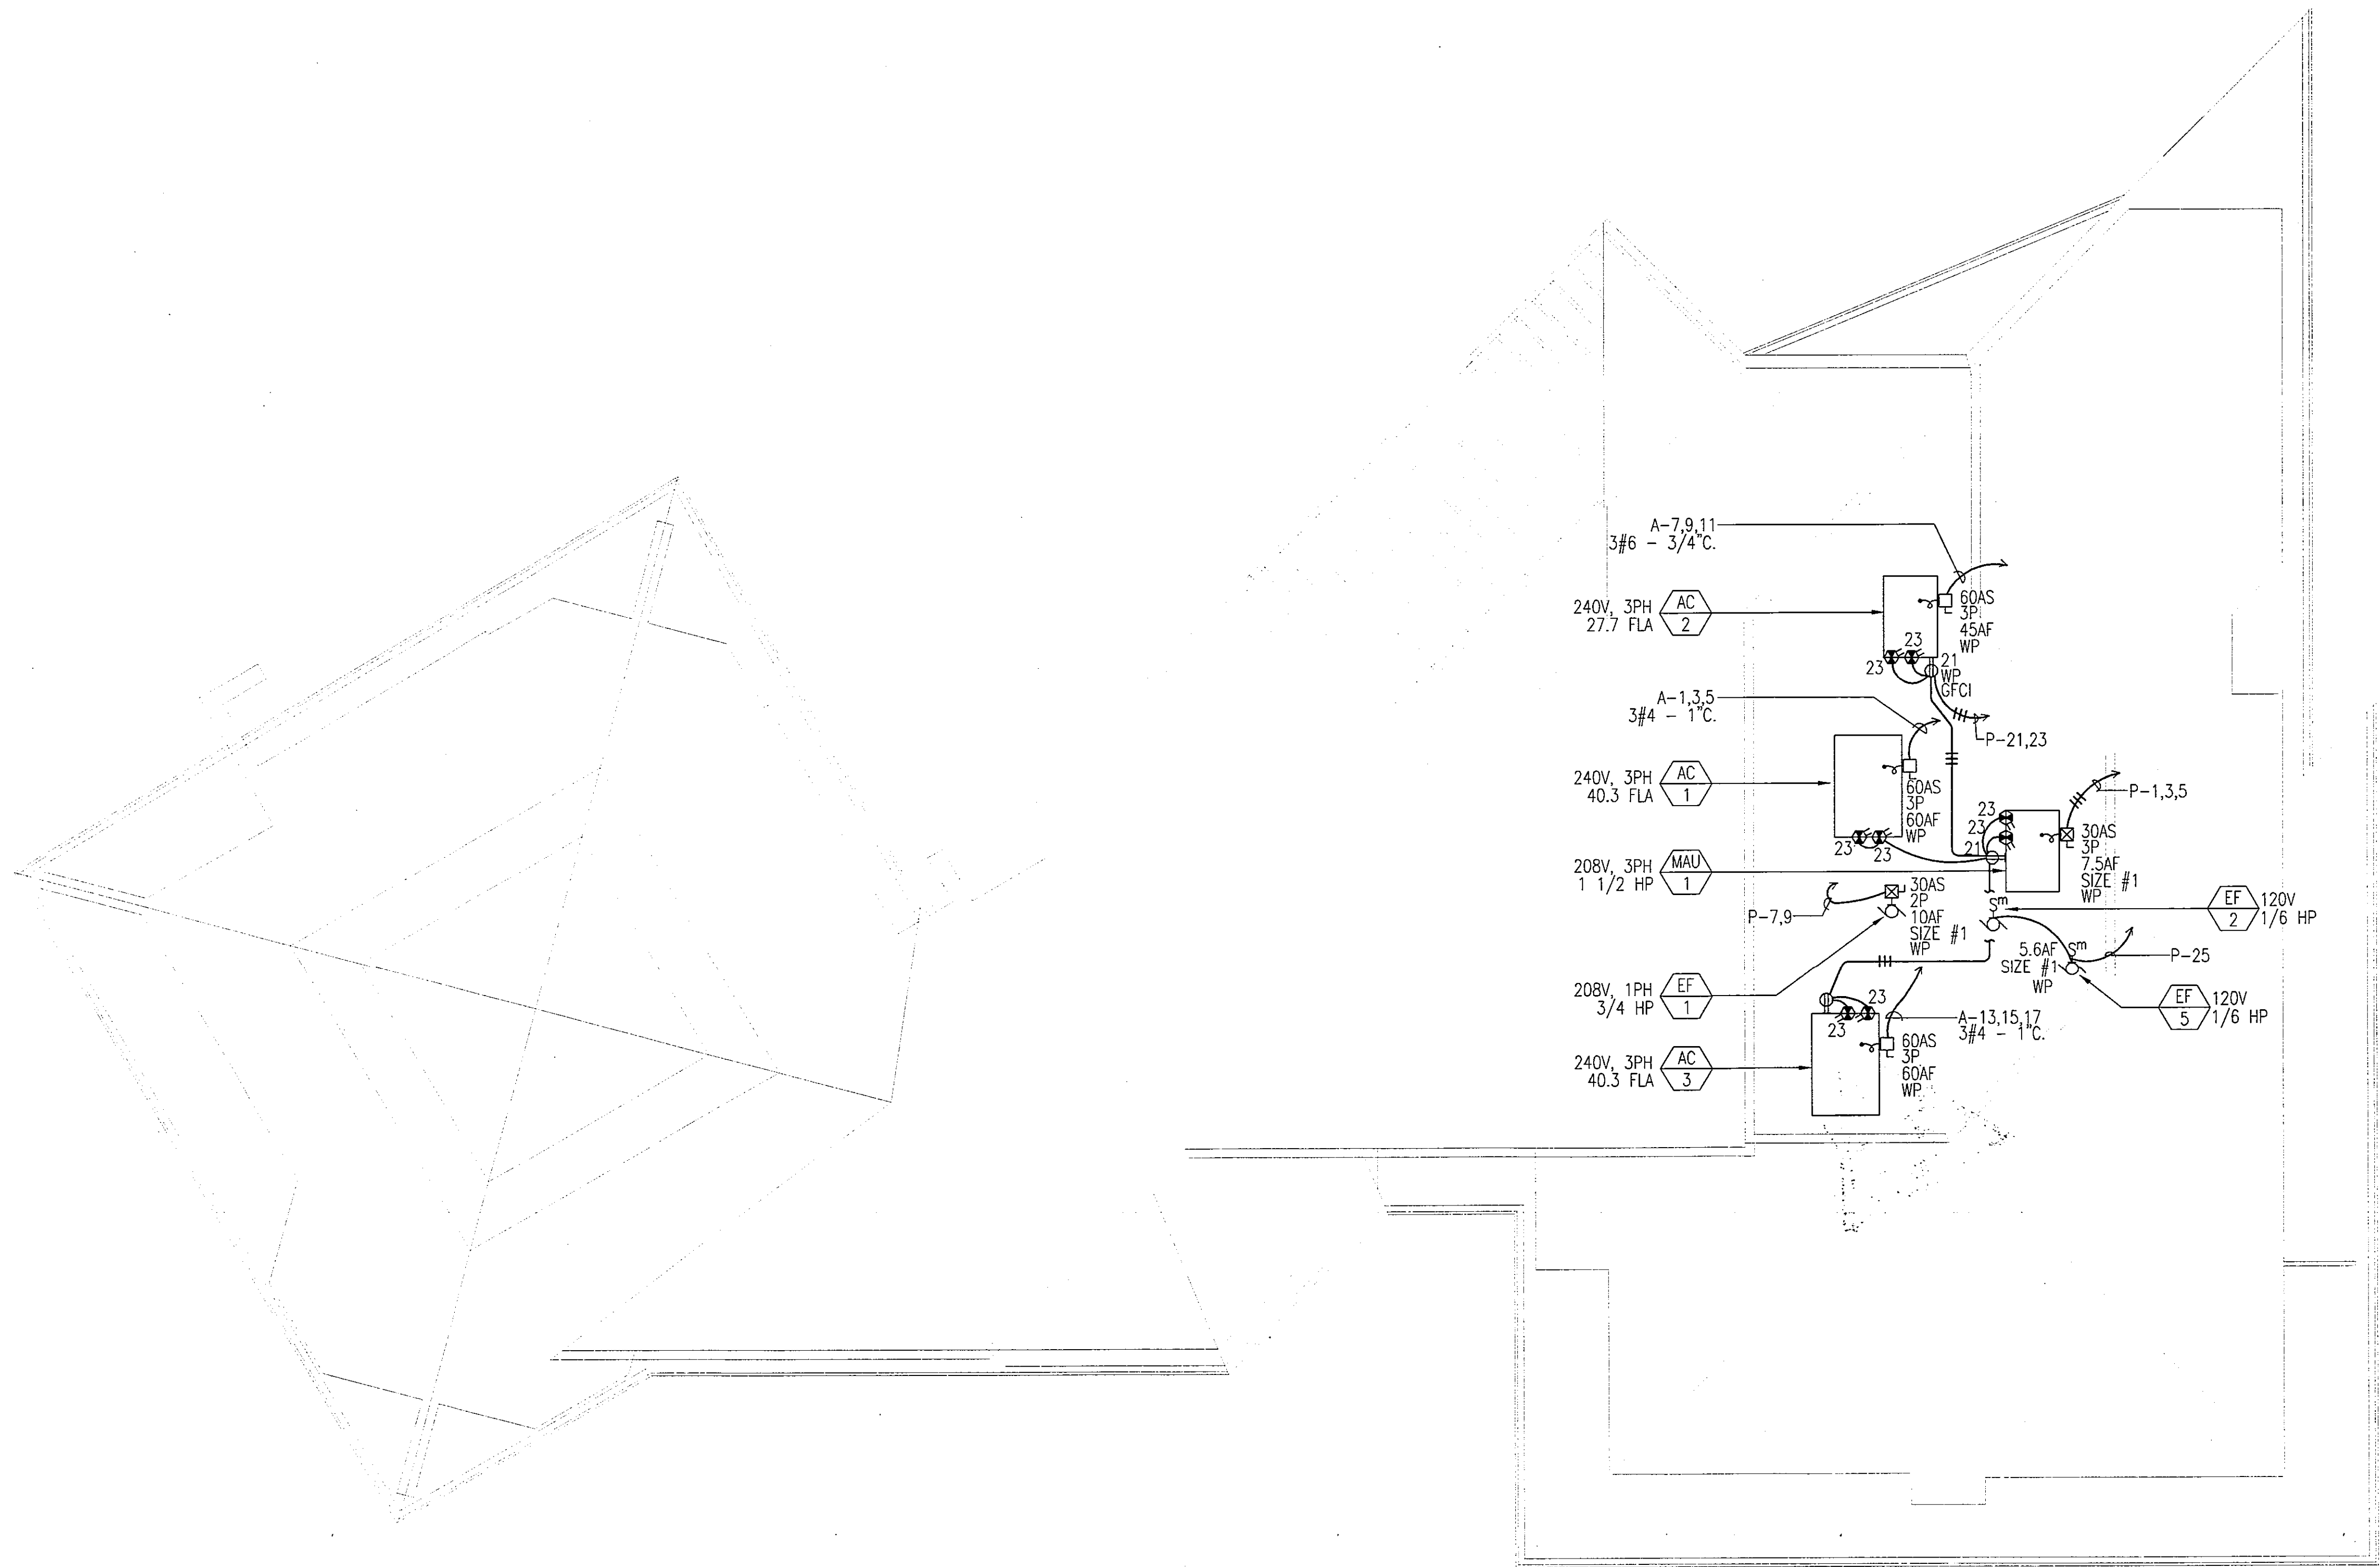

1. ALL EQUIPMENT INDICATED ON ROOF IS WEATHERPROOF.
2. ALL FUSES FOR FUSIBLE DISCONNECTS TO BE SIZED PER EQUIPMENT NAMEPLATES, TYPE RGS-1D.
3. SEE MECHANICAL DRAWINGS FOR CONTROLS AND OTHER WORK REQUIRED BUT NOT SHOWN HERE.
4. ROUTE ALL CONDUITS TO ROOF-TOP UNITS WITHIN ROOF-TOP UNITS AND HORIZONTALLY THROUGH ATTIC SPACE.
5. VERIFY EXACT LOCATION OF EQUIPMENT WITH MECHANICAL DRAWINGS.

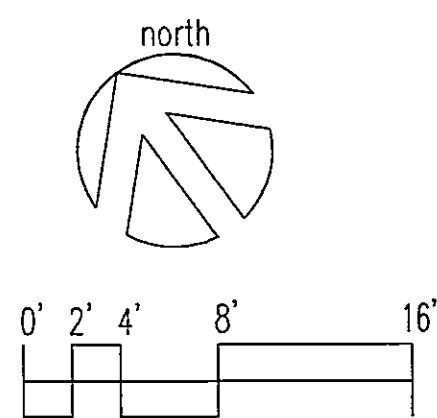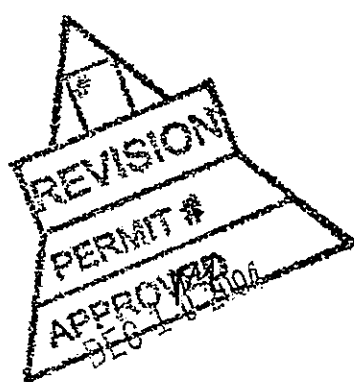

Scale: 1/8" = 1'-0"

POINT VICENTE INTERPRETIVE
CENTER EXPANSION
31501 Palos Verdes Drive West
Rancho Palos Verdes, CA

ELECTRICAL
ROOF PLAN




DRAWN
CHECKED
DATE
2-1-99
SCALE
1/8" = 1'-0"
JOB NO.
97356
SHEET
E-4
OF 69 SHEETS

ISSUE DATE: 1-5-04

IT COORDINATION 11-23-04

APPROVED
-ARCHITECT

Q.P. Engineering, Inc.
Mechanical and Electrical Engineers
1751 East Garry Avenue
Santa Ana, CA 92705-3814
Telephone (949) 428-8800
Fax (949) 428-8805

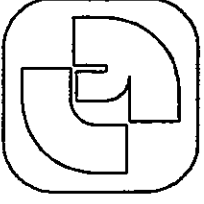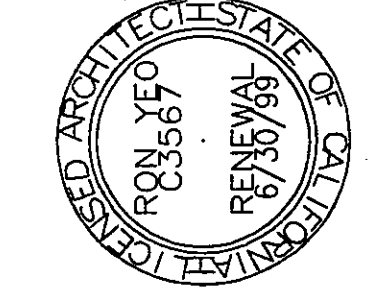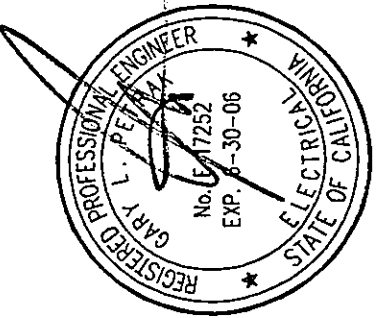

RON YEO, FAIA ARCHITECT, INC.
500 JASMINE AVENUE, CORONA DEL MAR
CALIFORNIA 92625-P714-844-8111 F714-644-0449
PATRICK MARR, AIA, PE, ASSOCIATE ARCHITECT

PLC EXPANSION Building Plans
Construction Set
1/31/04
1/31/04